



**University
of Victoria**

Facilities
Management

Facilities Notice

Title: Medical Sciences Building Exhaust Ductwork

Location: MSB 336 and 336f


Description: JB Sheet Metal will be working at night, making changes to exhaust ductwork to support a ducted biosafety cabinet in MSB 336f.

Time frame: November, 2017

Facilities Management contact: Rebecca Simmons, Project Manager


Email address: simmonsr@uvic.ca

Phone: 250-472-5011

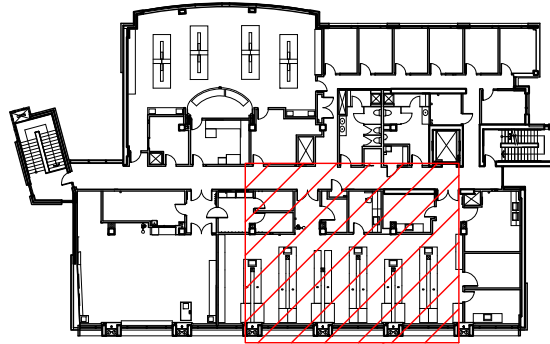

1 Floor Plan
NTS

Area Shown Below

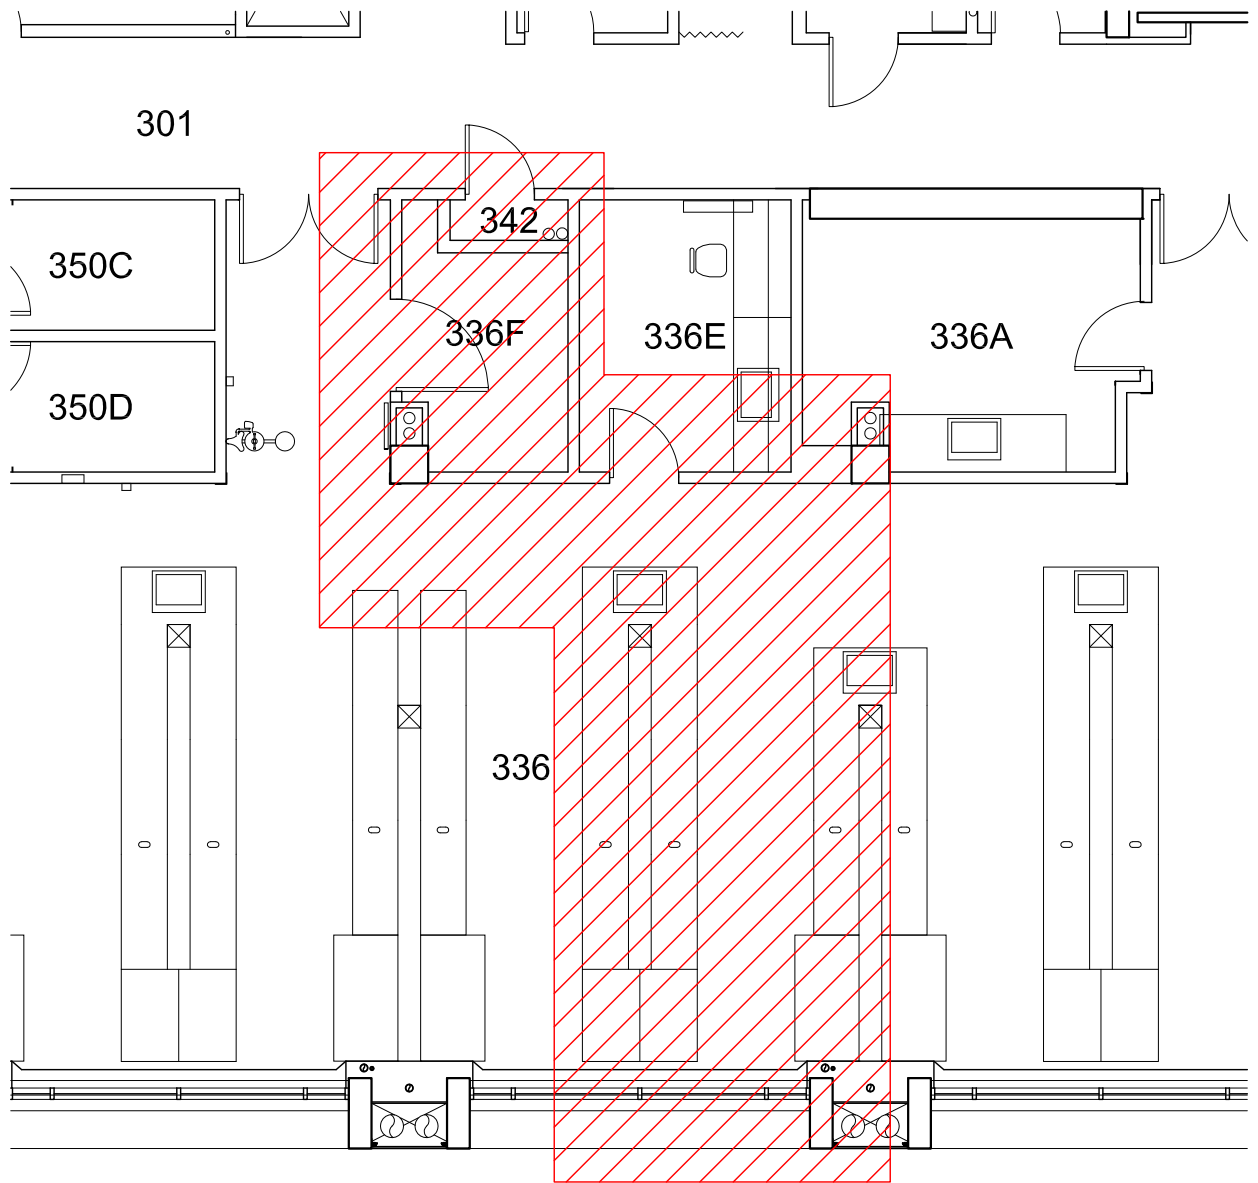

2 Area of Work
1:100



**University
of Victoria**

Facilities Management

Notes:
This drawing is for reference only. All site dimensions and conditions must be field-verified and reflected in all drawings submitted to UVic. The UVic title block is for FMGT use only. Modifications made to this document must be represented by the modifiers own title block. Any discrepancies found in UVic drawings must be communicated to UVic FMGT Project Manager assigned to the Project.

Title:
MSB 336 / 336f Ductwork
Area of Work

Date: 6 November 2017
Scale: 1:100
Drawn By: JW
Project Number: 16-02396
Drawing No.: SK1